

P S I E C M O H A L I

LAYOUT PLAN FOR INDUSTRIAL FOCAL POINT PHASE -V S.A.S. NAGAR (MOHALI)

**TOTAL AREA OF THE SCHEME:-
= 21.90 ACS.**

THIS DRAWING IS SUPERCEEDS PREVIOUS DRG.NO. LN-1/74.
16TH SEPTEMBER 1974.

NOTES:-

THE AREA OF THE 30'-0" WIDE BELT FOR OUT FALL SEWERAGE HAS ALREADY BEEN PREVIOUSLY ACQUIRED AND THERE-FOR WAS NOT INCLUDED IN THE PROPOSED ACQUIRED AREA OF 21.90 ACRES.

SOURCE:-

BOUNDARY OF THE SCHEME HAS BEEN TRACED FROM THE DRG.NO. D.T.P (P) 1071/73



**OFFICE OF
THE CHIEF ENGINEER,
PUNJAB SMALL
INDUSTRIES & EXPORT
CORPORATION UDYOG
BHAWAN, SECTOR:-17,
CHANDIGARH.**

SCALE :- 80'-0" TO AN INCH
JOB NO. / DRG. NO. :-
P-1/Z/SH-9/75

DATE :- 24-03-75

ASST. TOWN PLANNER:-

EXECUTIVE ENGINEER
CHIEF ENGINEER

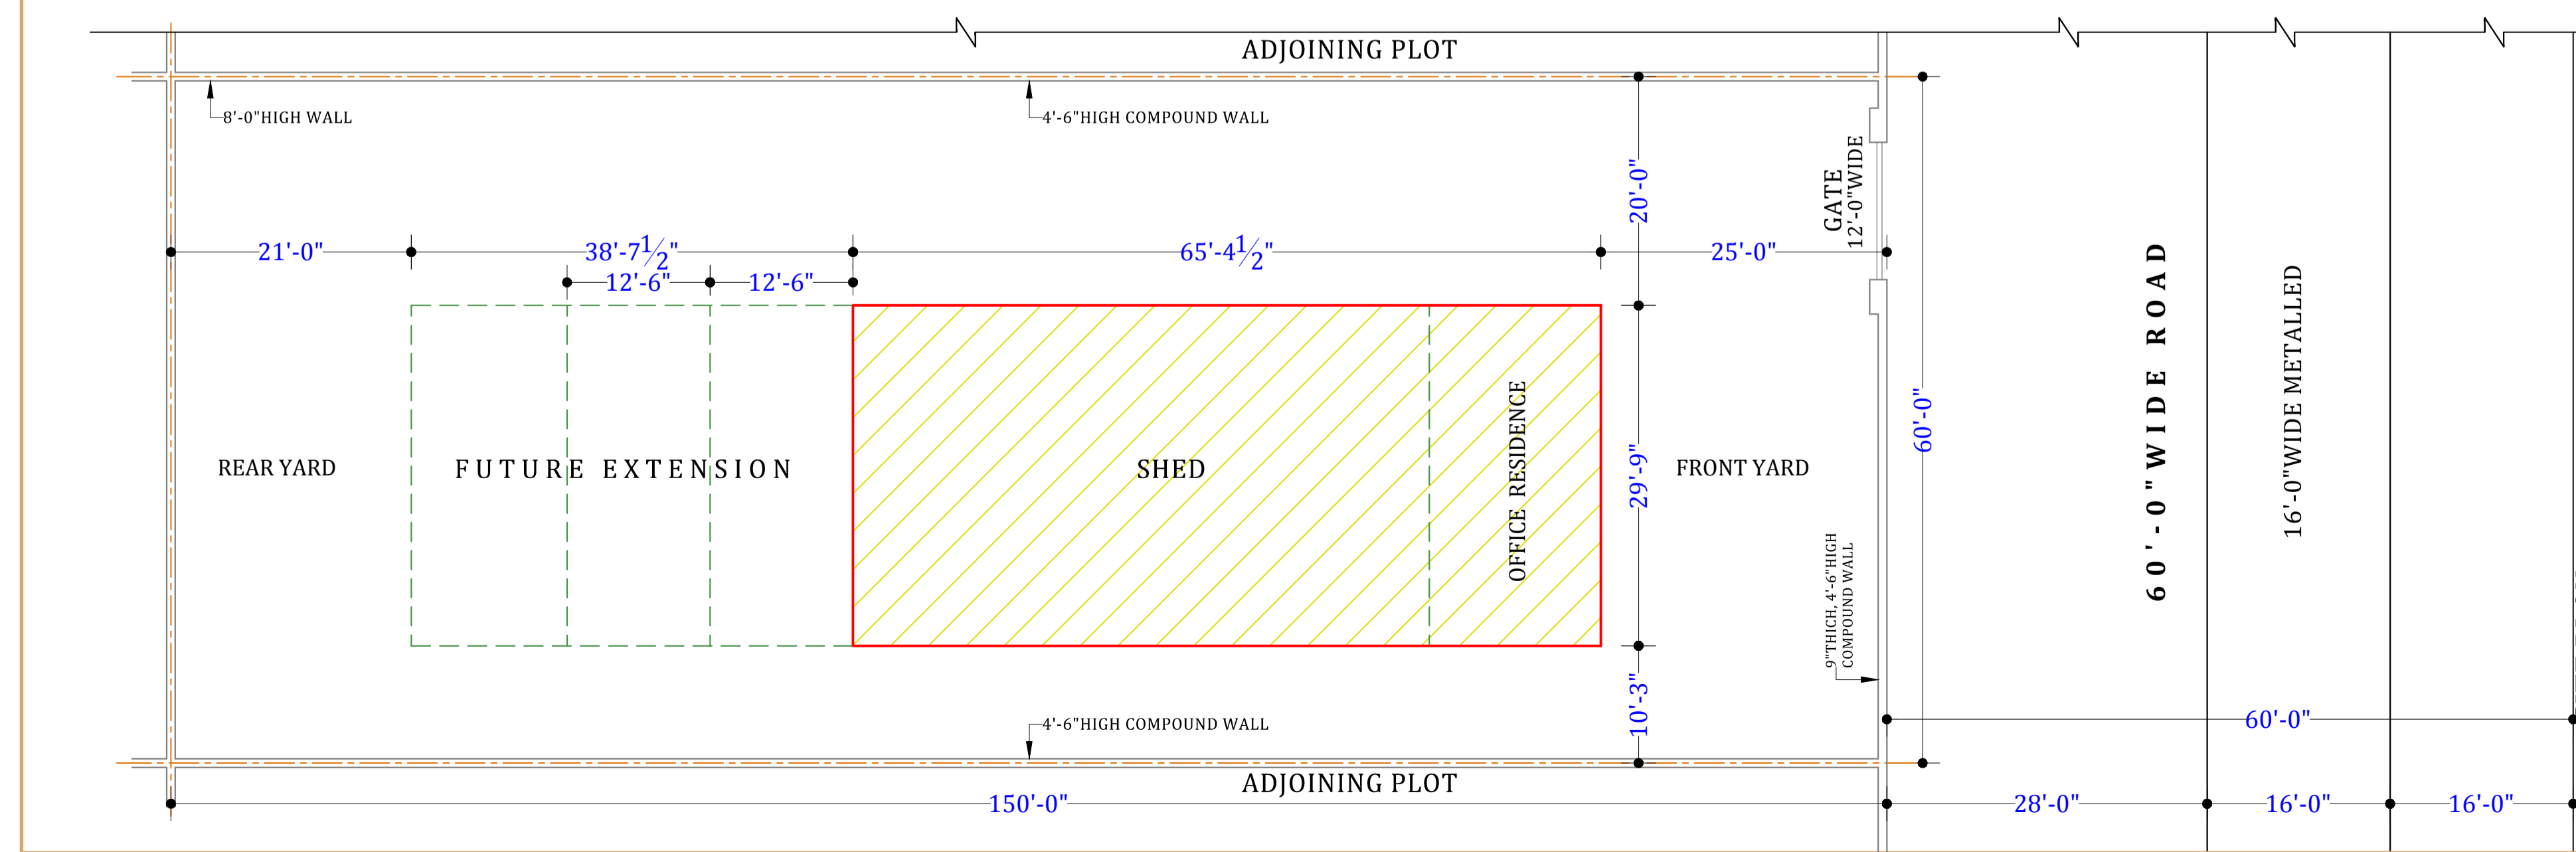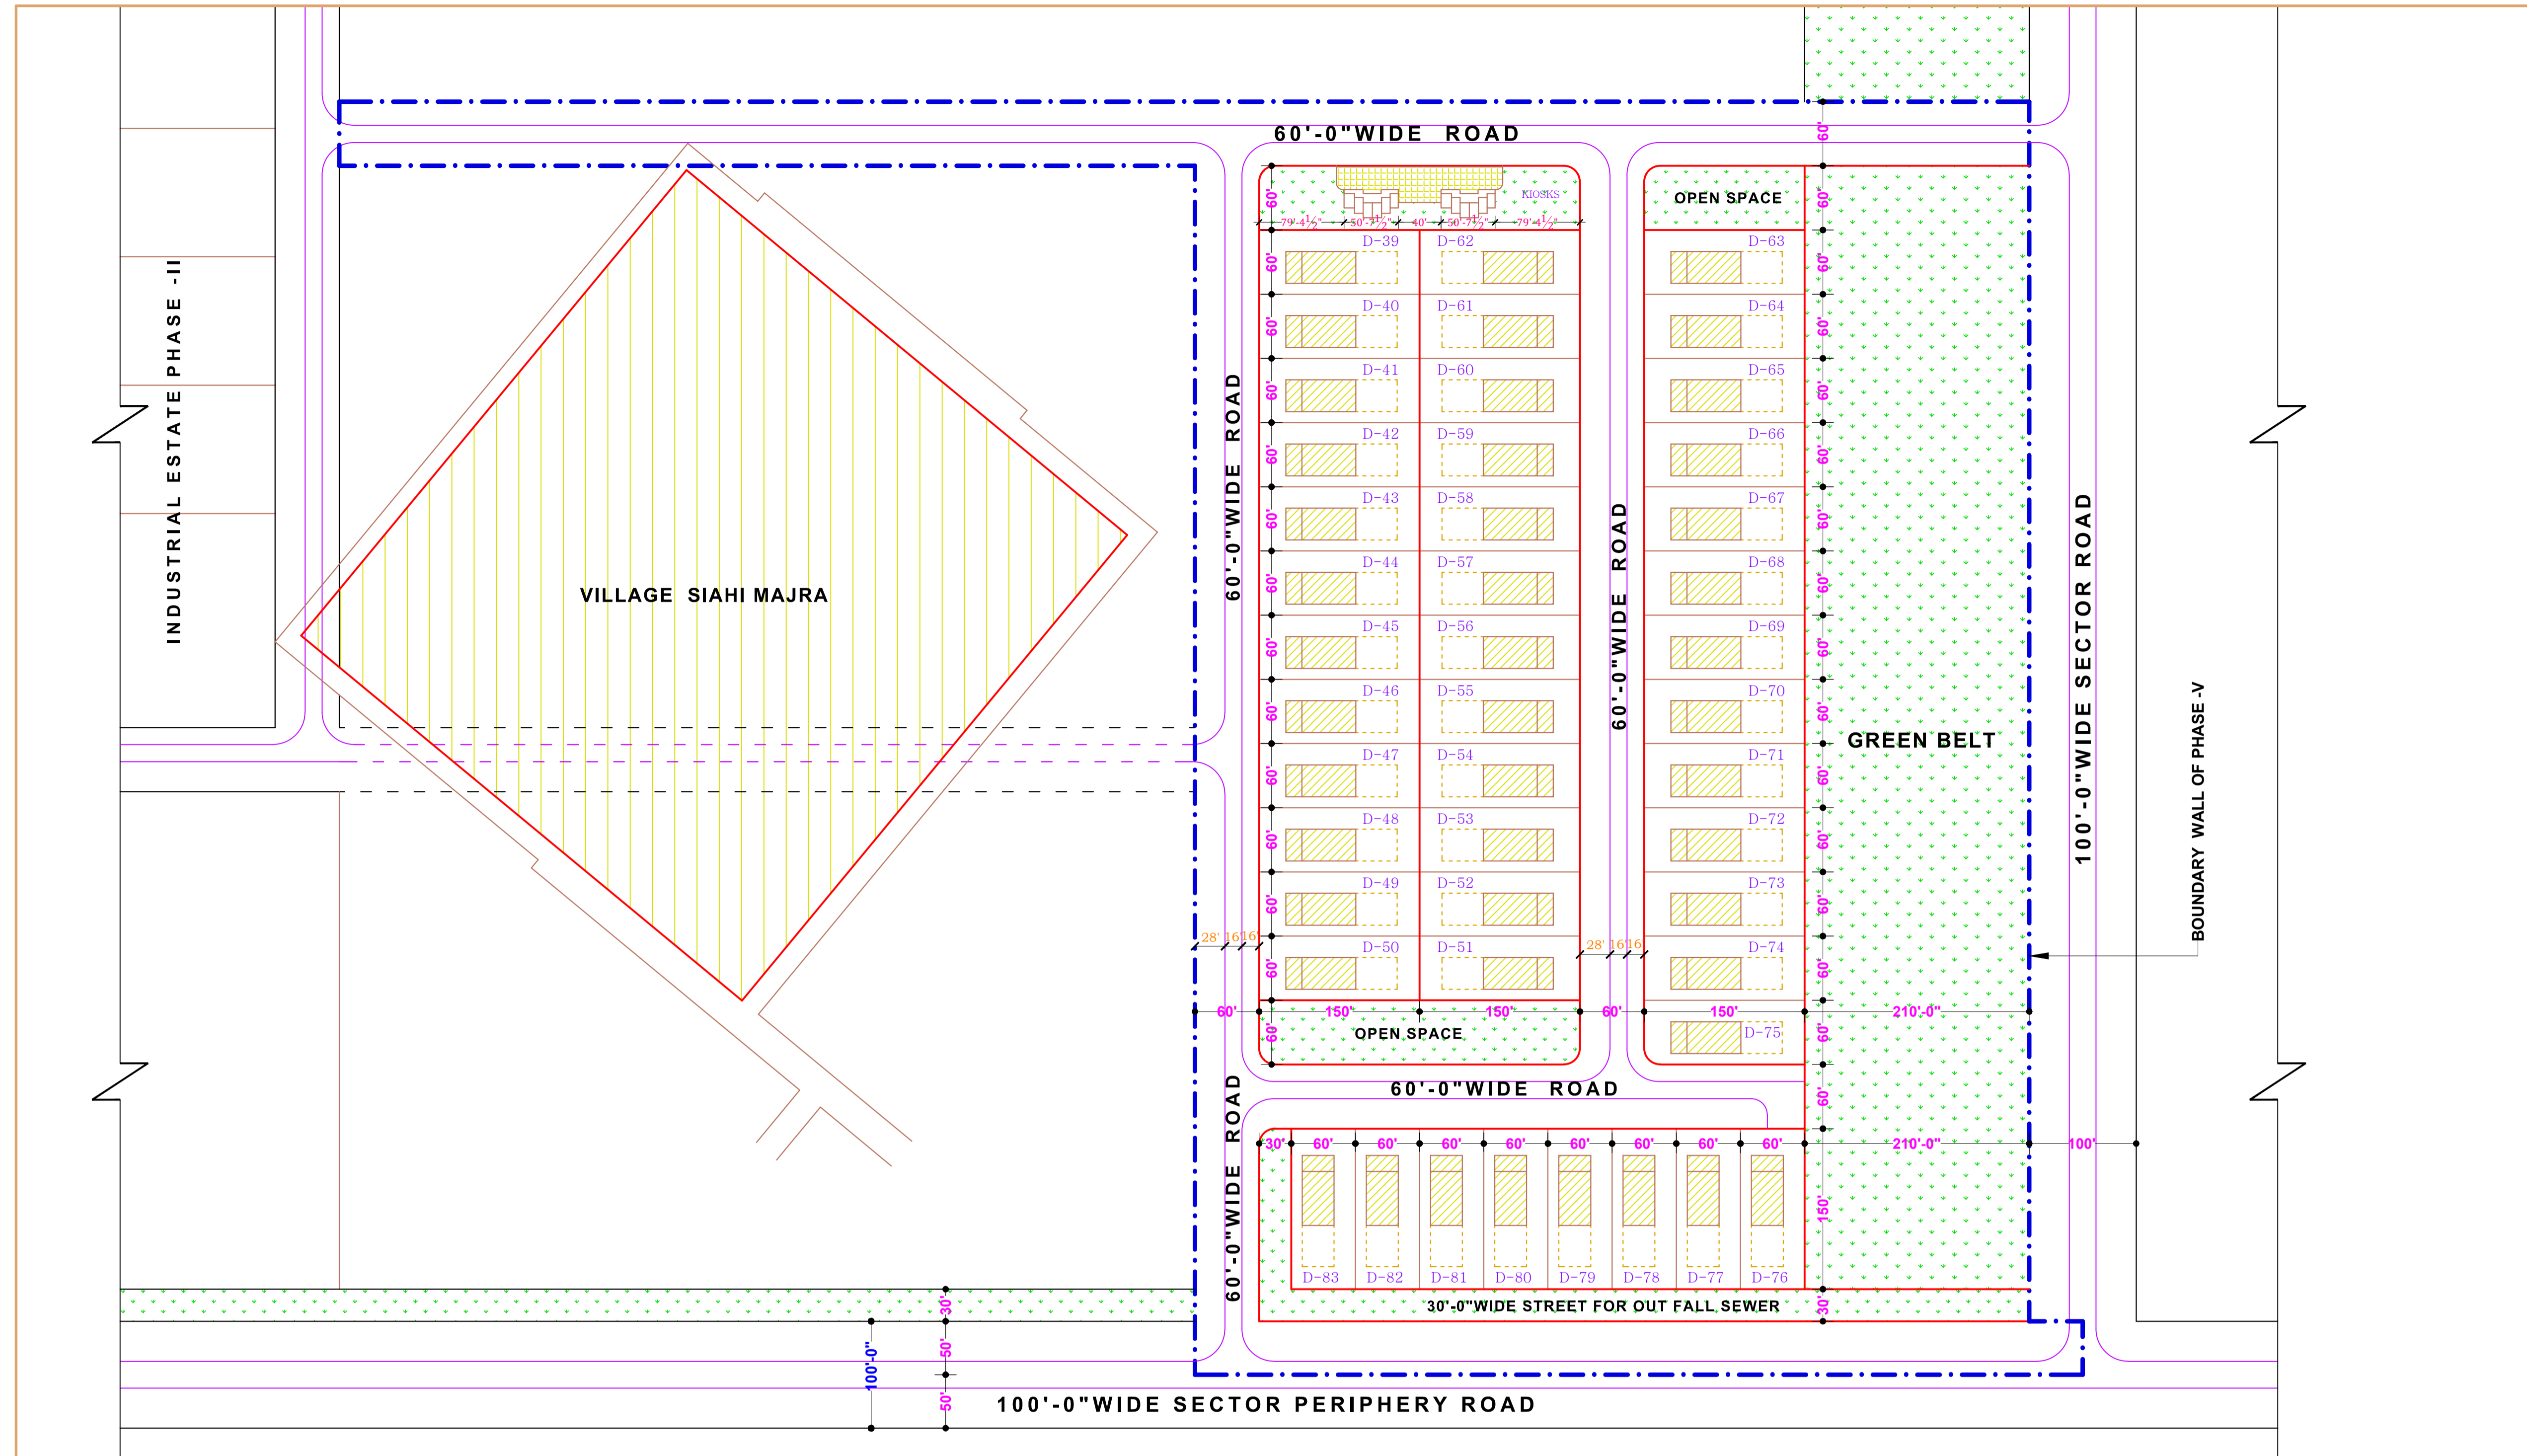

CIRCLE RATE (IN RS. PER SQ.YD.)	CATEGORY OF INDUSTRIES PERMITTED	DISTANCE FROM NEARBY CONNECTIVITY (IN KMS)			AVAILABILITY OF UTILITY SERVICES IN IFP	
		BUS STAND	RAILWAY STATION	MOHALI AIRPORT	ELECTRIC SUB-STATION	WATER WORKS
12500	ALL TYPE	3	8	12	NO	NO

NOTE:-
THIS DRAWING IS COMPUTERISED REPRODUCTION OF ORIGINAL JOB NO. / DRG. NO. P-1/Z/SH-9/75. DATED 24-03-75, AND PREPARED ON 22 / 09 / 2016.

**SITE PLAN
SCALE :- 10'-0" TO AN INCH.**

(VINOD DHIMAN) PREPARED BY :- J.D.M.	(VIKAS GUPTA) CHECKED BY :- J.D.M.
(SUKHDEV SINGH) PLANNING OFFICER :-	(J.S RANDHWA) GENERAL MANAGER PLANNING

